

DO NOT SCALE

Refer to Arboricultural documentation by OMC Associates for works in proximity to existing trees.

Latest survey suggests significant change in fence position and location of onsite trees. No dig solution required if tree retained and fence kept in existing position.

Alternatively, tree to be removed, fence line adjusted and path widened for full compliance.

Additional redesign required to reflect this change.


Path width and compliance to be confirmed by Building Control Consultants

White lining to be as per Cambridgeshire County Council Highways design standards.

-White lining to be as per Cambridgeshire County Council Highways design standards.

NOTES:
 DESIGN BASED ON ORIGINAL TOPOGRAPHICAL DATA BY ANGLIA LAND SURVEYS LTD (DRAWING REFERENCE AL56930/50007 TOPOGRAPHICAL, APRIL 2015)
 DESIGN BASED ON ARCHITECTURAL GROUND FLOOR PLAN AS PROVIDED AT DATE OF CONTRACT
 UNITS IN METERS UNLESS INDICATED OTHERWISE.
 DO NOT SCALE FROM THIS DRAWING.
 ALL DIMENSIONS TO BE CONFIRMED ON SITE.
 REFER TO ARBORICULTURAL DOCUMENTS AND DRAWINGS BEFORE COMMENCING WORKS.
 ALL WORKS TO BE CARRIED OUT IN ACCORDANCE WITH ARBORICULTURAL RECOMMENDATIONS / REQUIREMENTS.
 ALL WORKS TO BE CARRIED OUT IN ACCORDANCE WITH TREE SURVEY HANDBOOK SPECIFICATION (S138398-ATK-EXT-00-SP-L-0001) AND LANDSCAPE SOFTWARES SPECIFICATION (S138398-ATK-EXT-00-SP-L-0002).
 FOR FURTHER INFORMATION ON PLANTING AND SEEDING REFER TO TREE SURVEY HANDBOOK SPECIFICATION AND TURFING PLAN (S138398-ATK-EXT-00-DR-0003) AND ORNAMENTAL PLANTING PLAN (S138398-ATK-EXT-00-DR-0004)
 FOR LIGHTING CONDITIONS REFER TO PROPOSED EXTERNAL LIGHTING LAYOUT (CCC-CL-07-DR-00-DR-0001 & CCC-CL-07-DR-00-DR-0002) CEEETECH LIMITED

SHEET LOCATION PLAN (NTS)

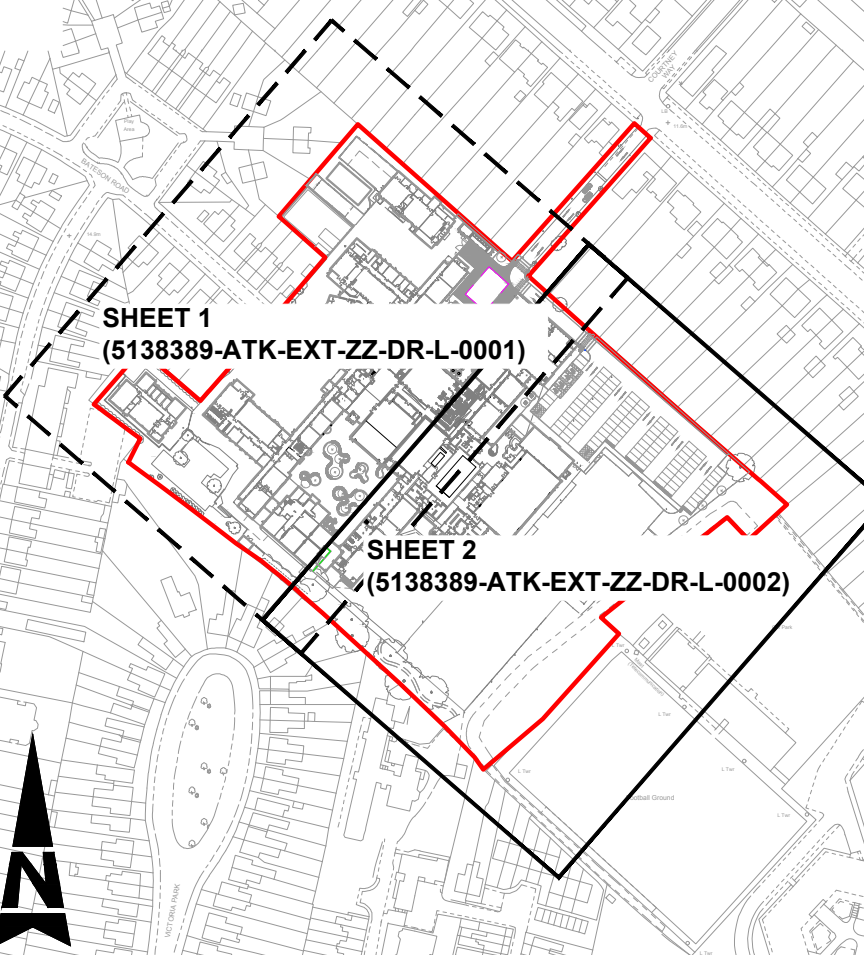

SAFETY, HEALTH AND ENVIRONMENTAL INFORMATION

In addition to the hazards/risks normally associated with the types of work detailed on this drawing, note the following:

CONSTRUCTION

U/A

MAINTENANCE/CLEANING

W/A

DECOMMISSIONING/DEMOLITION

W/A

It is assumed that all works will be carried out by a competent contractor working, where appropriate, to an approved method statement

P01	12.09.17	ORIGINAL	BC	JH	NM
Rev.	Date	Description	By	Chk'd	App'd
Drawing Status				Suitability	

growing status	FIT FOR TENDER	sustainability	D2
----------------	-----------------------	----------------	-----------

ATKINS

4th Floor
The Octagon
27 Middleborough
Colchester
CO1 1TG

Tel: +44 (0)1206 732000
Fax: +44 (0)1206 732020
www.atkinsglobal.com

Copyright © Atkins Limited (2017)



Cambridgeshire
County Council

Project Title

CHESTERTON COMMUNITY COLLEGE

Drawn Title

EXTERNAL GENERAL ARRANGEMENT
SHEET 2 OF 2

Scale 1:200	Designed BC	Drawn BC	Checked JH	Authorised NM
Original Size A0	Date 12/00/17	Date 12/00/17	Date 12/00/17	Date 12/00/17

Drawing Number	Revision
5138389-ATK-EXT-00-DR-L-0001	P01